


OAKCREST HOUSE
FIRST FLOOR - WEST
 SCALE: 3/32" = 1'-0"

SYMBOL SCHEDULE	
---	FIRE PARTITION - 2HR. RATED
---	SMOKE BARRIER PARTITION - 2HR. RATED
□	FIRE ALARM SYSTEM PULL STATION
⊙	FIRE ALARM SYSTEM SMOKE DETECTOR
⊙	FIRE ALARM SYSTEM DUCT DETECTOR
□	FIRE ALARM SYSTEM HORN
□	DOOR HOLDER
FACP	FIRE ALARM CONTROL PANEL
REMOTE FACP	REMOTE FIRE ALARM CONTROL PANEL
□	SPRINKLER FLOW SWITCH & TAMPER SWITCH
⊙	DOOR TAG
⊙	CEILING MOUNTED HORN/STROBE


DOOR SCHEDULE				
OPENING NUMBER	DOORS		FRAMES	LABEL
	MATERIAL	SIZE	MATERIAL	
101	H.M.	3'-0" X 6'-8" X 1-3/4"	METAL	3.0 HR.
102	H.M.	3'-0" X 6'-8" X 1-3/4"	METAL	3.0 HR.
103	H.M.	3'-6" X 6'-8" X 1-3/4"	METAL	3.0 HR.
104	H.M.	3'-0" X 6'-8" X 1-3/4"	WOOD	NONE
105	H.M.	3'-0" X 6'-8" X 1-3/4"	WOOD	NONE
106	H.M.	3'-0" X 6'-8" X 1-3/4"	WOOD	NONE
107	H.M.	3'-6" X 6'-8" X 2"	METAL	20 MIN.
108	H.M.	3'-6" X 6'-8" X 2"	METAL	20 MIN.
109	H.M.	3'-6" X 6'-8" X 2"	METAL	20 MIN.
110	H.M.	3'-6" X 6'-8" X 1-3/4"	METAL	???
111	H.M.	3'-0" X 6'-8" X 1-3/4"	METAL	1.5 HR.
112	H.M.	3'-6" X 6'-8" X 1-3/4"	METAL	1.5 HR.
113	H.M.	6'-0" X 6'-8" X 1-3/4"	METAL	20 MIN.
114	H.M.	3'-0" X 6'-8" X 1-3/4"	METAL	60 MIN.
115	H.M.	3'-6" X 6'-8" X 2"	METAL	60 MIN.
116	H.M.	3'-0" X 6'-8" X 1-3/4"	METAL	NONE
117	H.M.	3'-6" X 6'-8" X 1-3/4"	METAL	3.0 HR.
118	H.M.	3'-6" X 6'-8" X 1-3/4"	METAL	NONE
119	H.M.	3'-0" X 6'-8" X 1-3/4"	METAL	NONE
120	H.M.	3'-6" X 6'-8" X 1-3/4"	METAL	NONE
121	H.M.	3'-6" X 6'-8" X 1-3/4"	METAL	1.5 HR.
122	H.M.	3'-0" X 6'-8" X 1-3/4"	METAL	???

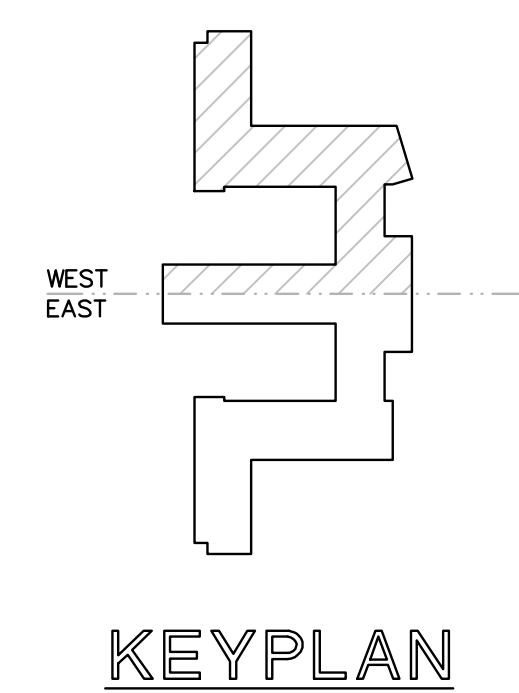

No.	Date	Description
1	05-15-2017	EDITED SYMBOL SCHEDULE

Daniel T. Calongne
 and
 Associates
7911 Winwood Blvd., Suite D
 Jackson, Louisiana 70223
 voice (225) 922-3223 fax (225) 922-2414

EASTERN LOUISIANA MENTAL HEALTH SYSTEM
 JACKSON, LOUISIANA
 LIFE SAFETY CODE DRAWINGS
 FOR VARIOUS BUILDINGS

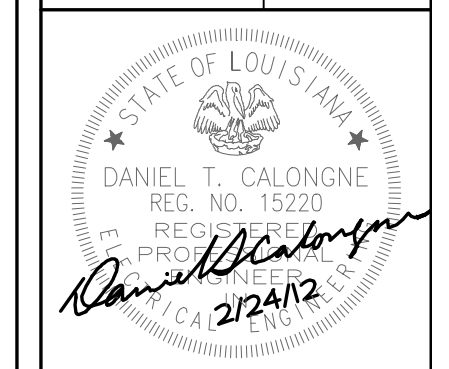

DRAWING TITLE
LIFE SAFETY PLAN
OAKCREST HOUSE
FIRST FLOOR
 Drawn: SNA
 Checked: DTC
 Date: 2-24-12
 Project No.: 11-077
 Sheet

LS-6.0
 10 of 15