


DOOR SCHEDULE 1st FLOOR				
OPENING NUMBER	DOORS		FRAMES	LABEL
	MATERIAL	SIZE		
1	METAL	2@ 3'-0" X 7'-0" X 1-3/4"	METAL	1.5 HR.
2	METAL	2@ 3'-0" X 7'-0" X 1-3/4"	METAL	1.5 HR.
3	METAL	3'-0" X 7'-0" X 1-3/4"	METAL	YES
4	WOOD	3'-0" X 7'-0" X 1-3/4"	METAL	NONE
5	WOOD	2'-8" X 7'-0" X 1-3/4"	METAL	NONE
6	WOOD	2'-8" X 7'-0" X 1-3/4"	METAL	NONE
7	METAL	2@ 3'-0" X 7'-0" X 1-3/4"	METAL	YES
8	METAL	4'-0" X 7'-0" X 1-3/4"	METAL	1.5 HR.
9	METAL	3'-8" X 7'-0" X 1-3/4"	METAL	1.5 HR.
10	METAL	3'-8" X 7'-0" X 1-3/4"	METAL	1.5 HR.
11	METAL	3'-8" X 7'-0" X 1-3/4"	METAL	1.5 HR.
12	METAL	3'-8" X 7'-0" X 1-3/4"	METAL	1.5 HR.
13	METAL	3'-8" X 7'-0" X 1-3/4"	METAL	1.5 HR.
14	METAL	3'-8" X 7'-0" X 1-3/4"	METAL	1.5 HR.
15	METAL	3'-8" X 7'-0" X 1-3/4"	METAL	1.5 HR.
16	METAL	3'-8" X 7'-0" X 1-3/4"	METAL	1.5 HR.

DOOR SCHEDULE 2nd FLOOR				
OPENING NUMBER	DOORS		FRAMES	LABEL
	MATERIAL	SIZE		
17	METAL	2@ 3'-0" X 7'-0" X 1-3/4"	METAL	1.5 HR.
18	METAL	2@ 3'-0" X 7'-0" X 1-3/4"	METAL	1.5 HR.
19	METAL	3'-0" X 7'-0" X 1-3/4"	METAL	YES
20	WOOD	3'-0" X 7'-0" X 1-3/4"	METAL	NONE
21	METAL	2'-8" X 7'-0" X 1-3/4"	METAL	YES
22	METAL	2'-8" X 7'-0" X 1-3/4"	METAL	YES
23	METAL	2@ 3'-0" X 7'-0" X 1-3/4"	METAL	YES
24	METAL	3'-8" X 7'-0" X 1-3/4"	METAL	1.5 HR.
25	METAL	3'-8" X 7'-0" X 1-3/4"	METAL	1.5 HR.
26	METAL	3'-8" X 7'-0" X 1-3/4"	METAL	1.5 HR.
27	METAL	3'-8" X 7'-0" X 1-3/4"	METAL	1.5 HR.
28	METAL	3'-8" X 7'-0" X 1-3/4"	METAL	1.5 HR.
29	METAL	3'-8" X 7'-0" X 1-3/4"	METAL	1.5 HR.
30	METAL	3'-8" X 7'-0" X 1-3/4"	METAL	1.5 HR.
31	METAL	3'-8" X 7'-0" X 1-3/4"	METAL	1.5 HR.

NORTH  
**2 DORTHEA DIX / DD BUILDING**  
**2 SECOND FLOOR**  
 SCALE: 1/8" = 1'-0"

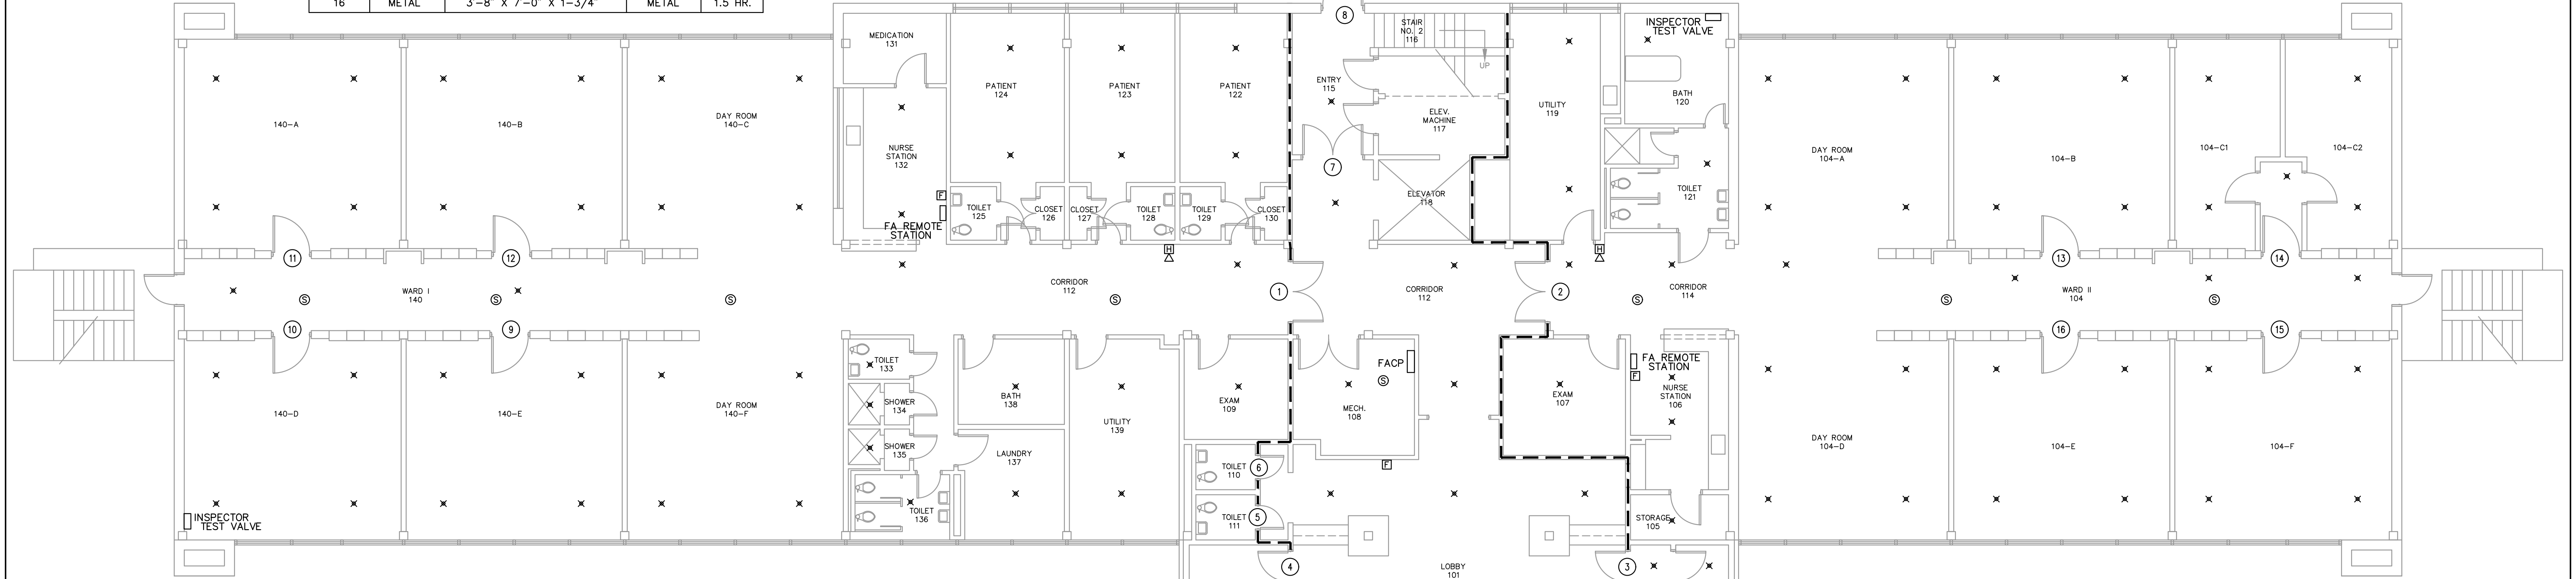

SYMBOL SCHEDULE	
---	FIRE PARTITION - 2HR. RATED
---	SMOKE BARRIER PARTITION - 2HR. RATED
☐	FIRE ALARM SYSTEM PULL STATION
⊙	FIRE ALARM SYSTEM SMOKE DETECTOR
⊕	FIRE ALARM SYSTEM DUCT DETECTOR
☐	FIRE ALARM SYSTEM HORN OR HORN/STROBE
☐	DOOR HOLDER
☐	FACP
☐	REMOTE FACP
☐	SPRINKLER FLOW SWITCH & TAMPER SWITCH
⊙	DOOR TAG
⊙	CEILING MOUNTED HORN/STROBE
x	SPRINKLER HEAD

NORTH  
**1 DORTHEA DIX / DD BUILDING**  
**1 FIRST FLOOR**  
 SCALE: 1/8" = 1'-0"

No.	Date	Description
1	05-15-2017	EDITED SYMBOL SCHEDULE


**AS**

**Daniel T. Calogne**  
and  
Associates

7914 Merewood Blvd., Suite 200  
Baton Rouge, LA 70809  
voice (225)922-9223 fax (225)922-9414

**EASTERN LOUISIANA MENTAL HEALTH SYSTEM**  
 JACKSON, LOUISIANA

LIFE SAFETY CODE DRAWINGS  
 FOR VARIOUS BUILDINGS

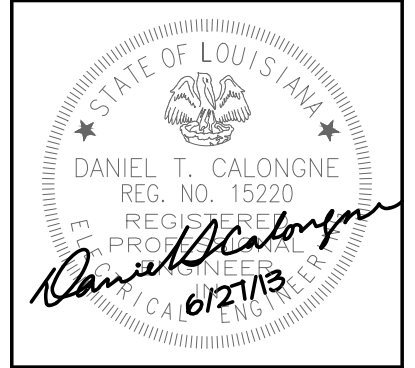

DRAWING TITLE	
LIFE SAFETY PLAN DORTHEA DIX BUILDING DD	
Drawn:	RDW
Checked:	DTC
Date:	6-25-13
Project No.:	11-077
Sheet	
<b>LS-8.0</b>	
- of -	