



SYMBOL SCHEDULE	
----	FIRE PARTITION - 2HR. RATED
----	SMOKE BARRIER PARTITION - 2HR. RATED
□	FIRE ALARM SYSTEM PULL STATION
⊙	FIRE ALARM SYSTEM SMOKE DETECTOR
⊕	FIRE ALARM SYSTEM DUCT DETECTOR
⊞	FIRE ALARM SYSTEM HORN
⊞	DOOR HOLDER
FACP	FIRE ALARM CONTROL PANEL
REMOTE FACP	REMOTE FIRE ALARM CONTROL PANEL
⊞	SPRINKLER FLOW SWITCH & TAMPER SWITCH
⊞	DOOR TAG
⊞	CEILING MOUNTED HORN/STROBE

DOOR SCHEDULE					
OPENING NUMBER	DOORS		FRAMES	LABEL	
	MATERIAL	SIZE	MATERIAL		
1	WOOD	1'- 11-1/2" x 7'-0" x 1-3/4"	METAL	NONE	
2	WOOD	3'-0" x 7'-0" x 1-3/4"	METAL	NONE	
3	WOOD	3'- 3-1/2" x 7'-0" x 1-7/8"	METAL	NONE	
4	WOOD	3'- 3-1/2" x 7'-0" x 1-7/8"	METAL	NONE	
5	WOOD	3'-0" x 7'-0" x 1-3/4"	METAL	NONE	
6	WOOD	3'- 3-1/2" x 7'-0" x 1-7/8"	METAL	NONE	
7	WOOD	1'- 11-1/2" x 7'-0" x 1-3/4"	METAL	NONE	

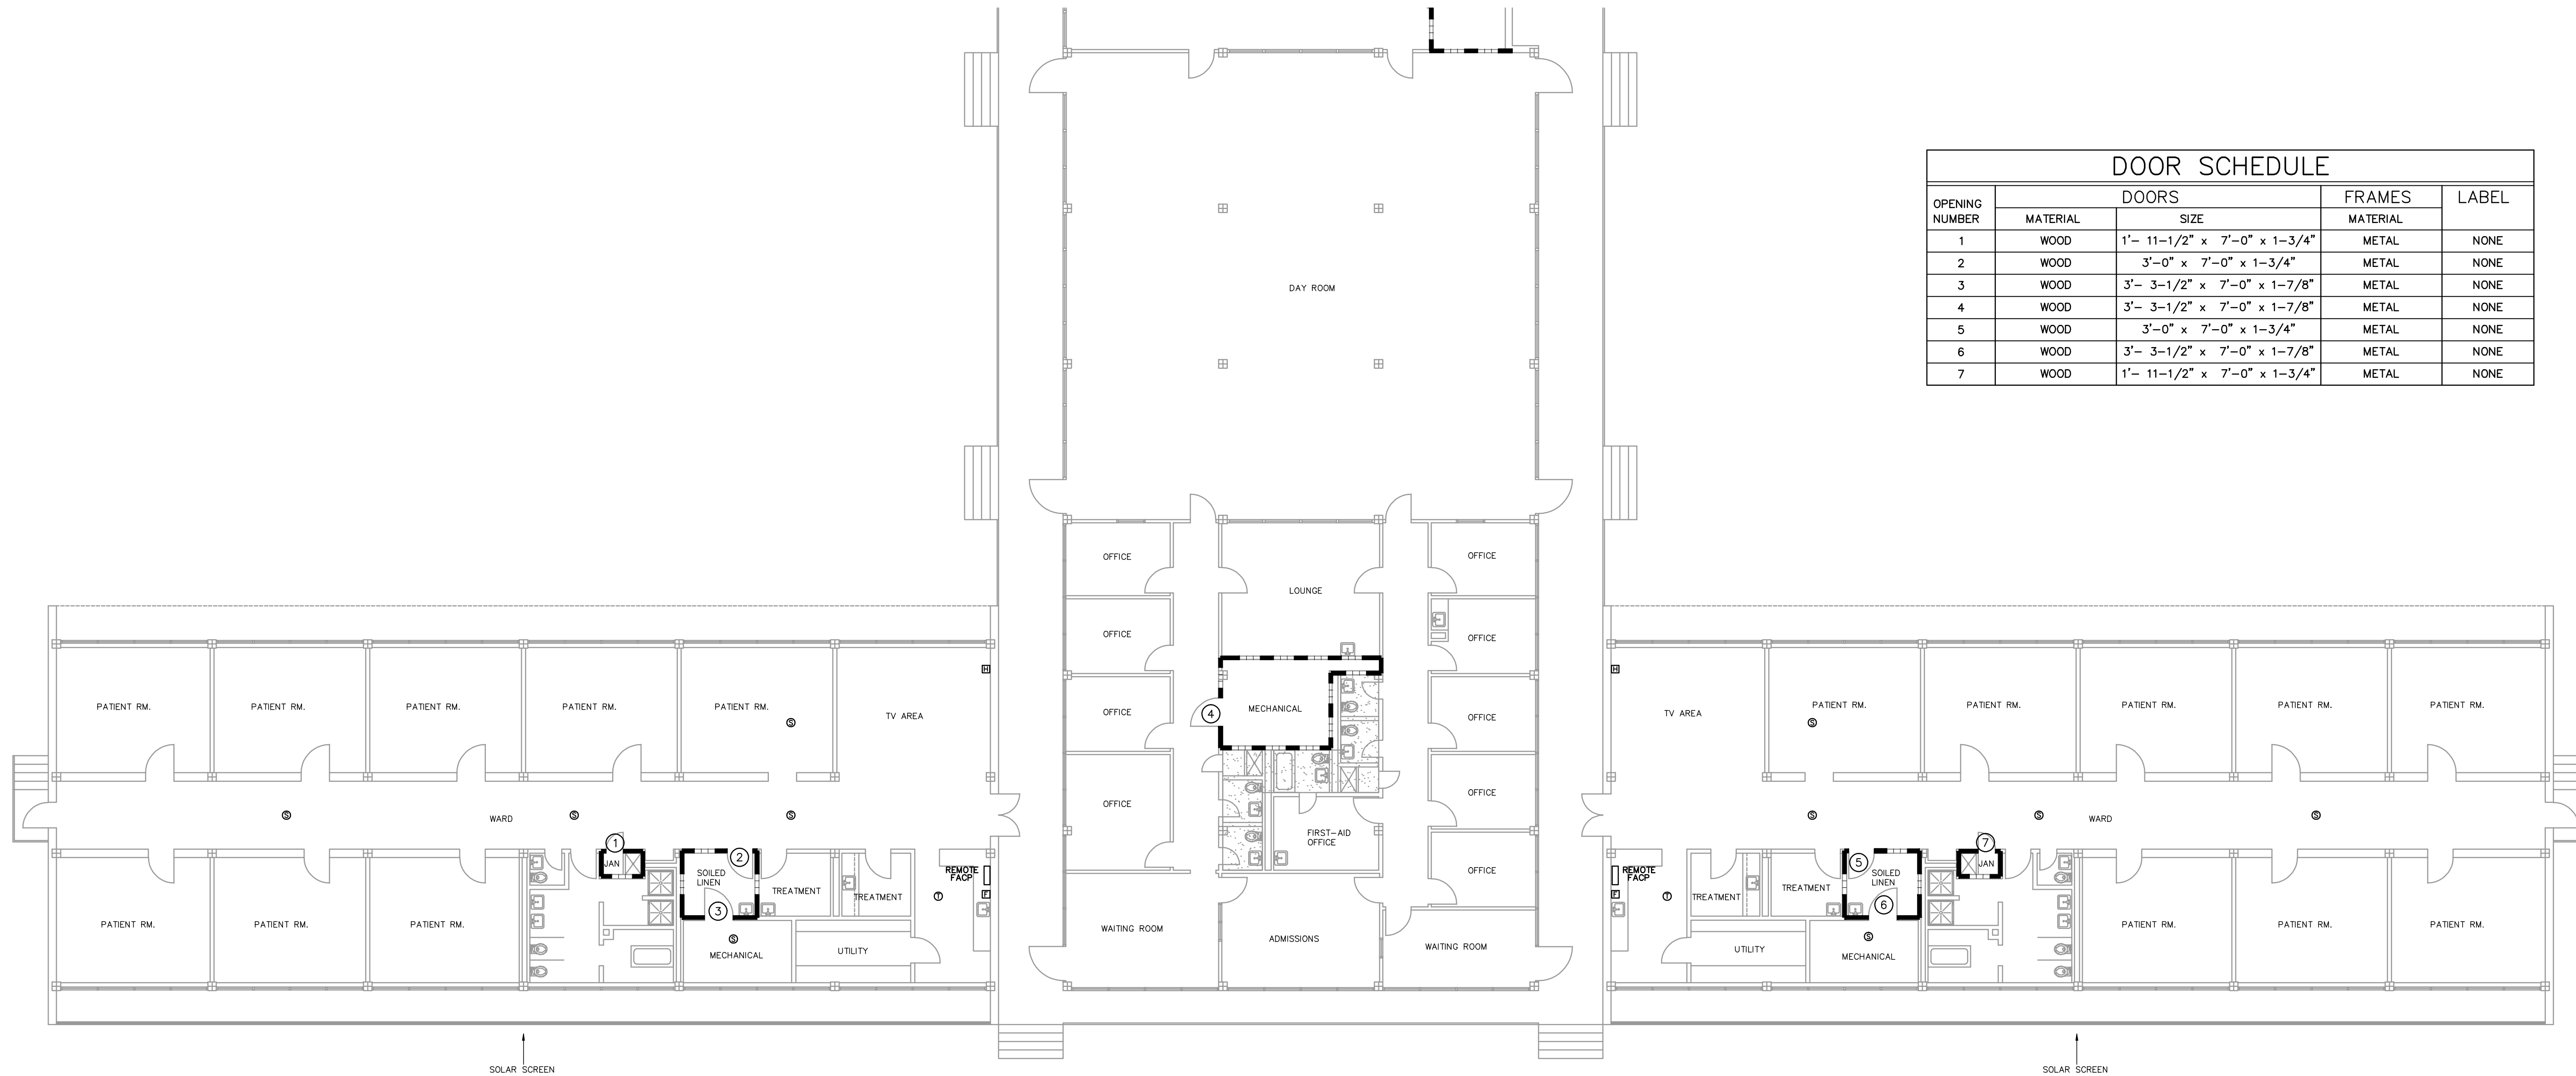


GABRIEL HOUSE - NORTH FLOOR PLAN
 SCALE: 3/32" = 1'-0"

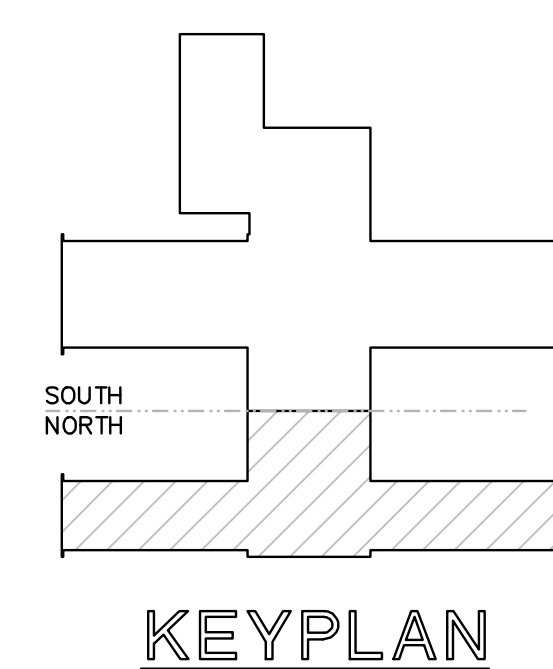

No.	Date	Description
1	05-15-2017	EDITED SYMBOL SCHEDULE

ASCOES
Daniel T. Calongne and Associates
 7911 Winwood Blvd., Suite D
 Jackson, Louisiana 70221
 voice (225) 922-3223 fax (225) 922-2414

EASTERN LOUISIANA MENTAL HEALTH SYSTEM
 JACKSON, LOUISIANA
 LIFE SAFETY CODE DRAWINGS
 FOR VARIOUS BUILDINGS

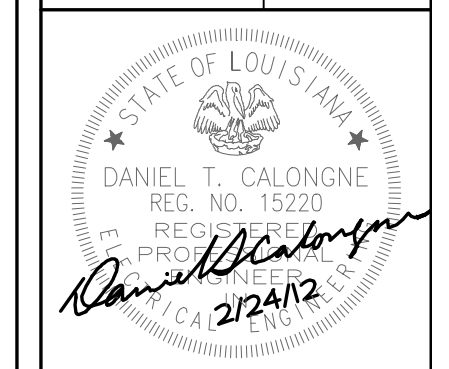

DRAWING TITLE
 LIFE SAFETY PLAN
 GABRIEL HOUSE
 NORTH PLAN
 Drawn: SNA
 Checked: DTC
 Date: 2-24-12
 Project No.: 11-077
 Sheet

LS-4.0
 6 of 15